


DOOR SCHEDULE				
MARK	DOOR SIZE			NOTES
	WD	HGT	THK	
001	9'-0"	7'-0"	PER MFR.	GARAGE DOOR
002	9'-0"	7'-0"	PER MFR.	GARAGE DOOR
003	3'-0"	6'-8"	PER MFR.	EXTERIOR DOOR
004	9'-0"	7'-0"	PER MFR.	GARAGE DOOR
005	3'-0"	6'-8"	PER MFR.	-
006	3'-0"	6'-8"	PER MFR.	-
007	3'-0"	6'-8"	PER MFR.	-
008	3'-0"	6'-8"	PER MFR.	-
009	6'-0"	6'-8"	PER MFR.	EXTERIOR DOUBLE DOOR

NOTES:

WINDOW SCHEDULE				
MARK	SIZE		TYPE	NOTES
	WIDTH	HEIGHT		
A	3'-0"	5'-6"	DOUBLE HUNG	-
B	3'-0"	4'-0"	DOUBLE HUNG	-
C	4'-0"	5'-6"	DOUBLE HUNG	-
D	2'-0"	3'-0"	DOUBLE HUNG	-
E	3'-0"	3'-0"	DOUBLE HUNG	-
F	3'-0"	5'-0"	DOUBLE HUNG	-

NOTES:

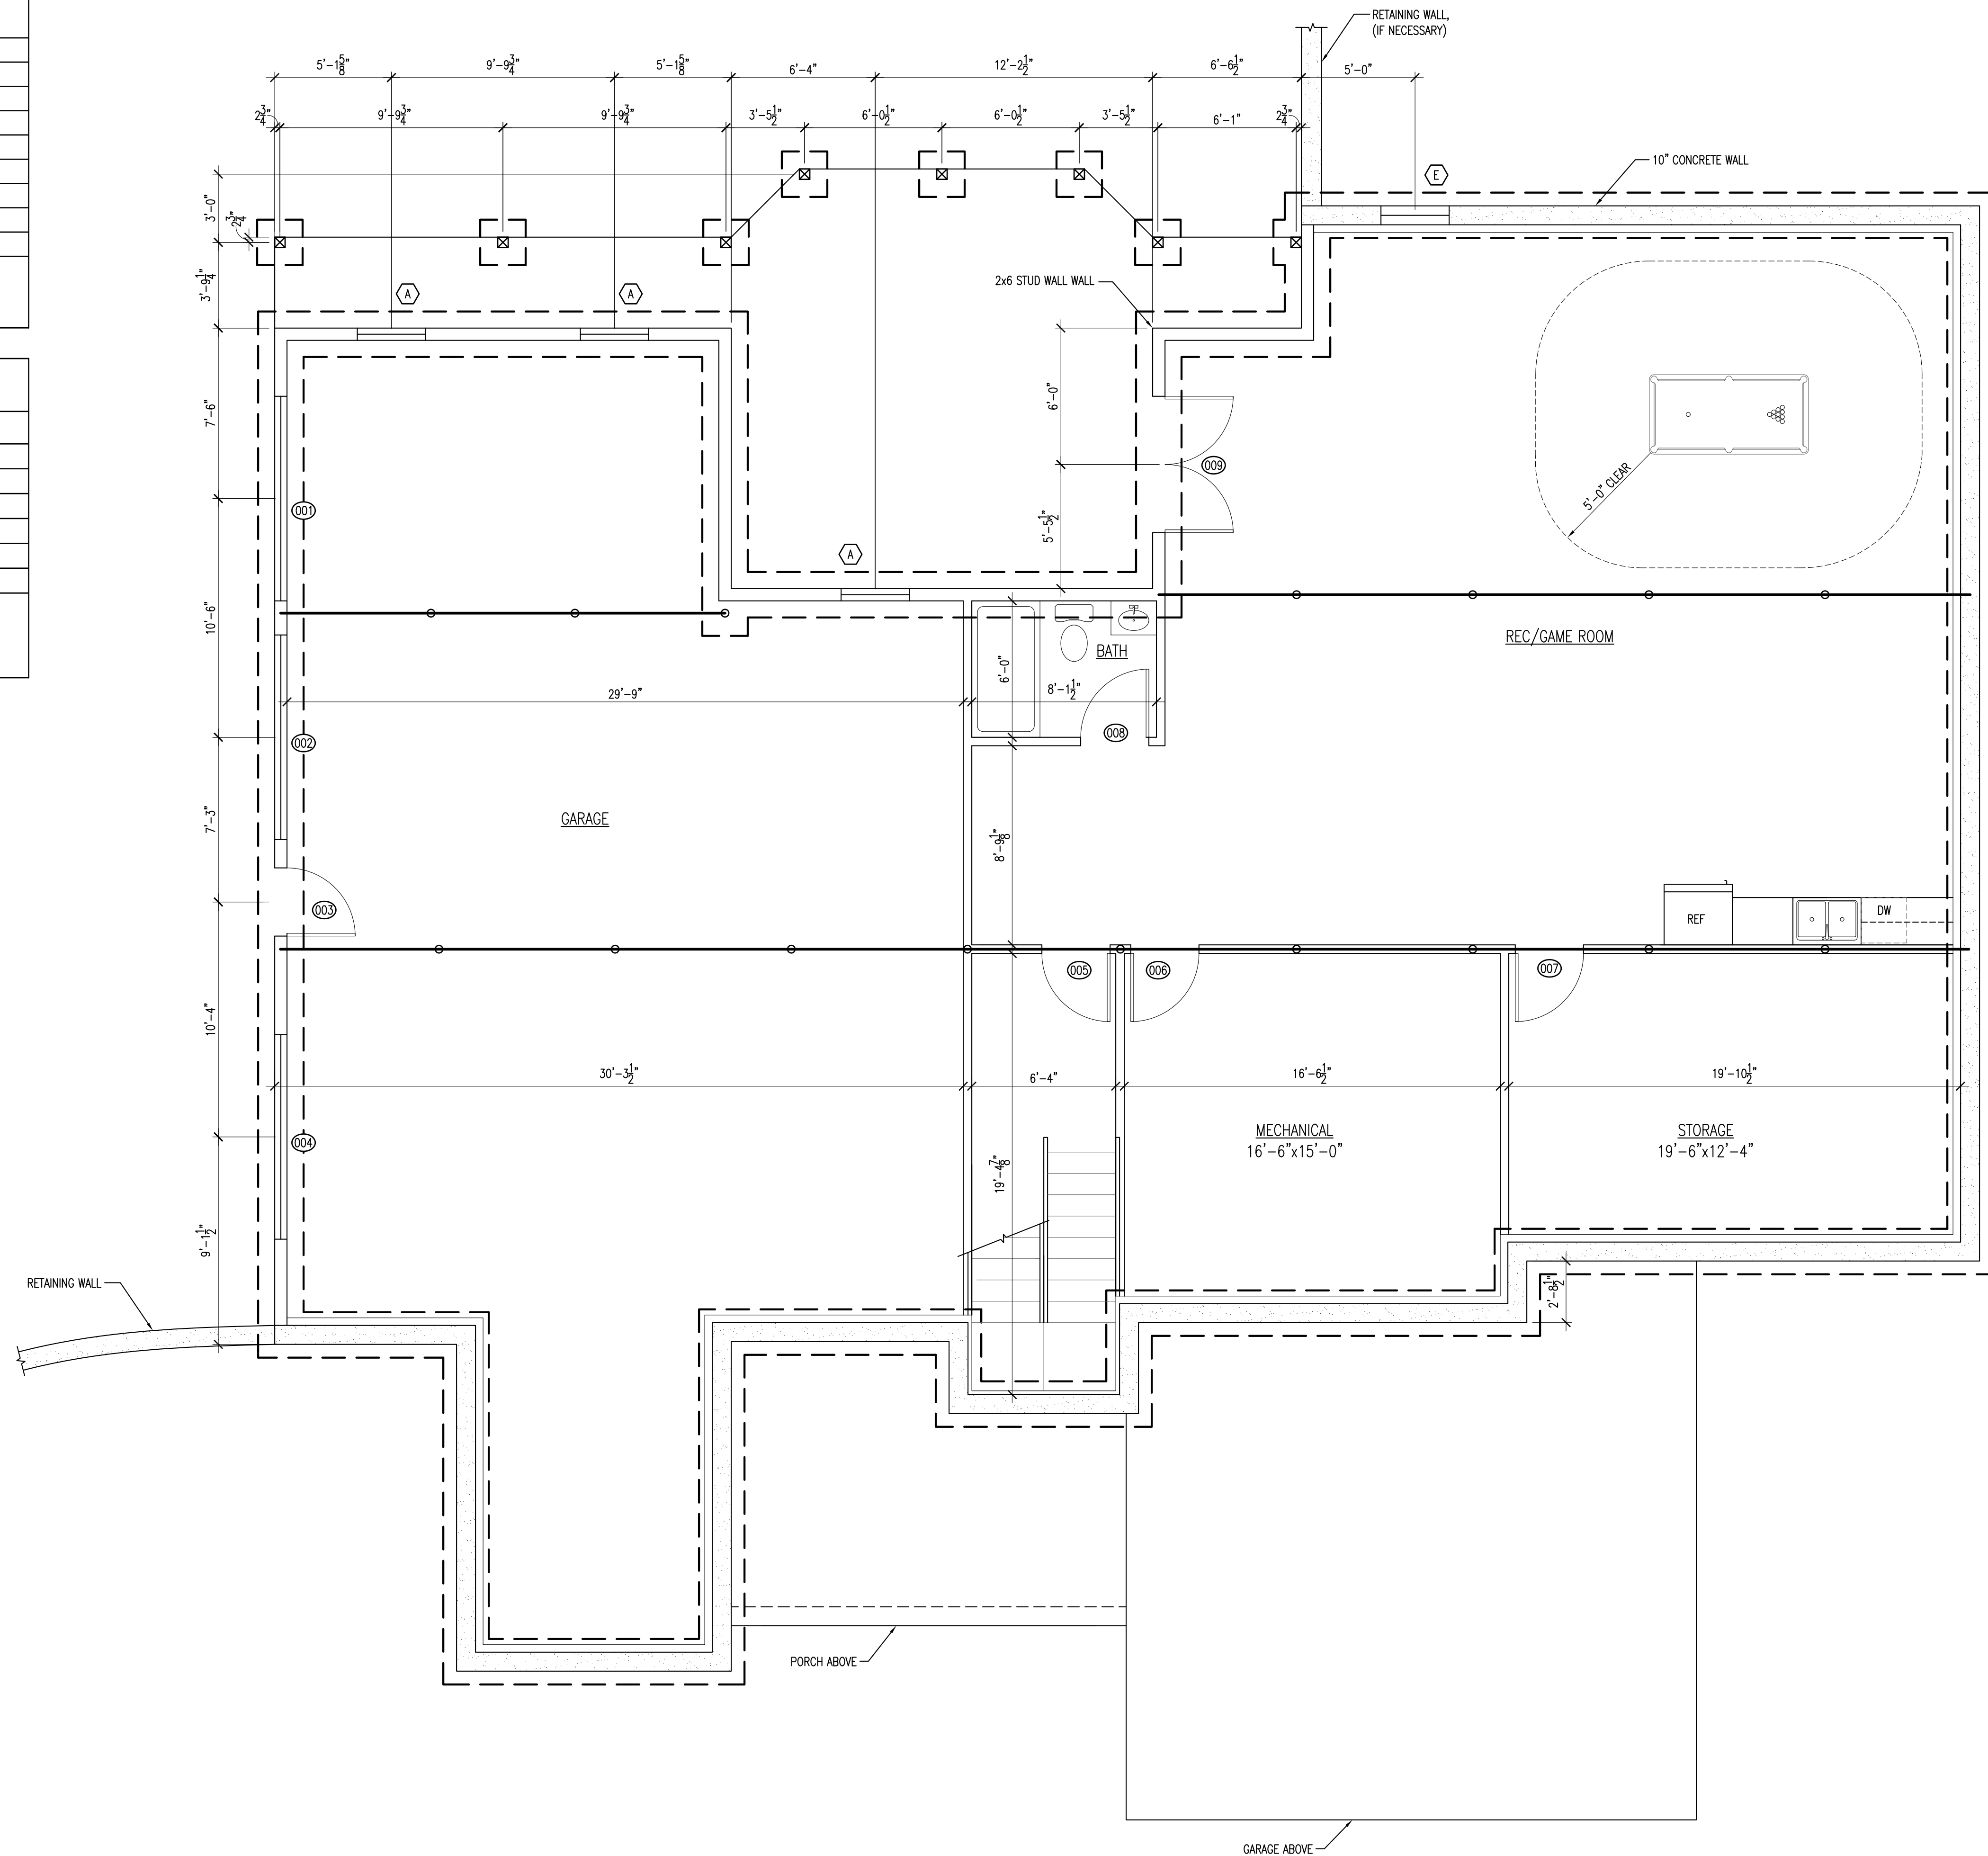

ALL DESIGN SHOWN HAS BEEN UNDER THE DIRECTION OF THE OWNER, SCOTT HILL. NO CODE CHECKS HAVE BEEN PERFORMED. GC SHALL COORDINATE ALL DESIGN REQUIREMENTS ON ACCORDANCE WITH THE VIRGINIA UNIFORM STATEWIDE BUILDING CODE.

IF THIS BAR IS NOT EXACTLY ONE INCH LONG, THIS DRAWING HAS NOT BEEN REPRODUCED AT FULL SCALE

PROJECT
 HILL RESIDENCE
 PEAKLAND WAY LOT 63
 MONTGOMERY COUNTY, VA

REV.	DESCRIPTION	DATE

SHEET NAME
 FOUNDATION PLAN

PROJECT NO. 08-1103	SHEET A1
DATE 13-JAN-09	1 OF 06

ALL DESIGN SHOWN HAS BEEN UNDER THE DIRECTION OF THE OWNER, SCOTT HILL. NO CODE CHECKS HAVE BEEN PERFORMED. GC SHALL COORDINATE ALL DESIGN REQUIREMENTS ON ACCORDANCE WITH THE VIRGINIA UNIFORM STATEWIDE BUILDING CODE.

IF THIS BAR IS NOT EXACTLY ONE INCH LONG, THIS DRAWING HAS NOT BEEN REPRODUCED AT FULL SCALE

PROJECT
HILL RESIDENCE
PEAKLAND WAY LOT 63
MONTGOMERY COUNTY, VA

REV.	DESCRIPTION	DATE

SHEET NAME
FIRST FLOOR PLAN & SCHEDULES

PROJECT NO. 08-1103	SHEET A2
DATE 13-JAN-09	02 OF 06

DOOR SCHEDULE

MARK	DOOR SIZE			NOTES
	WD	HGT	THK	
101	3'-0"	6'-8"	PER MFR.	EXTERIOR DOOR w/ SIDE LIGHTS
102	3'-0"	6'-8"	PER MFR.	-
103	3'-0"	6'-8"	PER MFR.	POCKET DOOR
104	3'-0"	6'-8"	PER MFR.	-
105	3'-0"	6'-8"	PER MFR.	-
106	18'-0"	7'-0"	PER MFR.	OVERHEAD GARAGE DOOR
107	5'-0"	6'-8"	PER MFR.	DOUBLE DOOR
108	3'-0"	6'-8"	PER MFR.	-
109	2'-8"	6'-8"	PER MFR.	DOUBLE DOOR
110	3'-0"	6'-8"	PER MFR.	POCKET DOOR
111	3'-0"	6'-8"	PER MFR.	POCKET DOOR
112	2'-0"	6'-8"	PER MFR.	-
113	3'-0"	6'-8"	PER MFR.	POCKET DOOR
114	3'-0"	6'-8"	PER MFR.	-
115	3'-0"	6'-8"	PER MFR.	-
116	5'-0"	6'-8"	PER MFR.	DOUBLE DOOR
117	3'-0"	6'-8"	PER MFR.	-
118	6'-0"	6'-8"	PER MFR.	EXTERIOR DOUBLE DOOR
119	6'-0"	6'-8"	PER MFR.	EXTERIOR DOUBLE DOOR
120	3'-0"	6'-8"	PER MFR.	-
121	6'-0"	6'-8"	PER MFR.	EXTERIOR DOUBLE DOOR
122	3'-0"	6'-8"	PER MFR.	POCKET DOOR
123	3'-0"	6'-8"	PER MFR.	POCKET DOOR
124	3'-0"	6'-8"	PER MFR.	POCKET DOOR
125	3'-0"	6'-8"	PER MFR.	POCKET DOOR
126	3'-0"	6'-8"	PER MFR.	-
127	3'-0"	6'-8"	PER MFR.	POCKET DOOR


NOTES:

WINDOW SCHEDULE

MARK	SIZE		TYPE	NOTES
	WIDTH	HEIGHT		
A	3'-0"	5'-6"	DOUBLE HUNG	-
B	3'-0"	4'-0"	DOUBLE HUNG	-
C	4'-0"	5'-6"	DOUBLE HUNG	-
D	2'-0"	3'-0"	DOUBLE HUNG	-
E	3'-0"	3'-0"	DOUBLE HUNG	-
F	3'-0"	5'-0"	DOUBLE HUNG	-

NOTES:

NOTE:
 ALL EXTERIOR WALLS SHOWN AS 6 1/2" THICK & ALL INTERIOR WALLS SHOWN AS 4 1/2" THICK U.N.O.

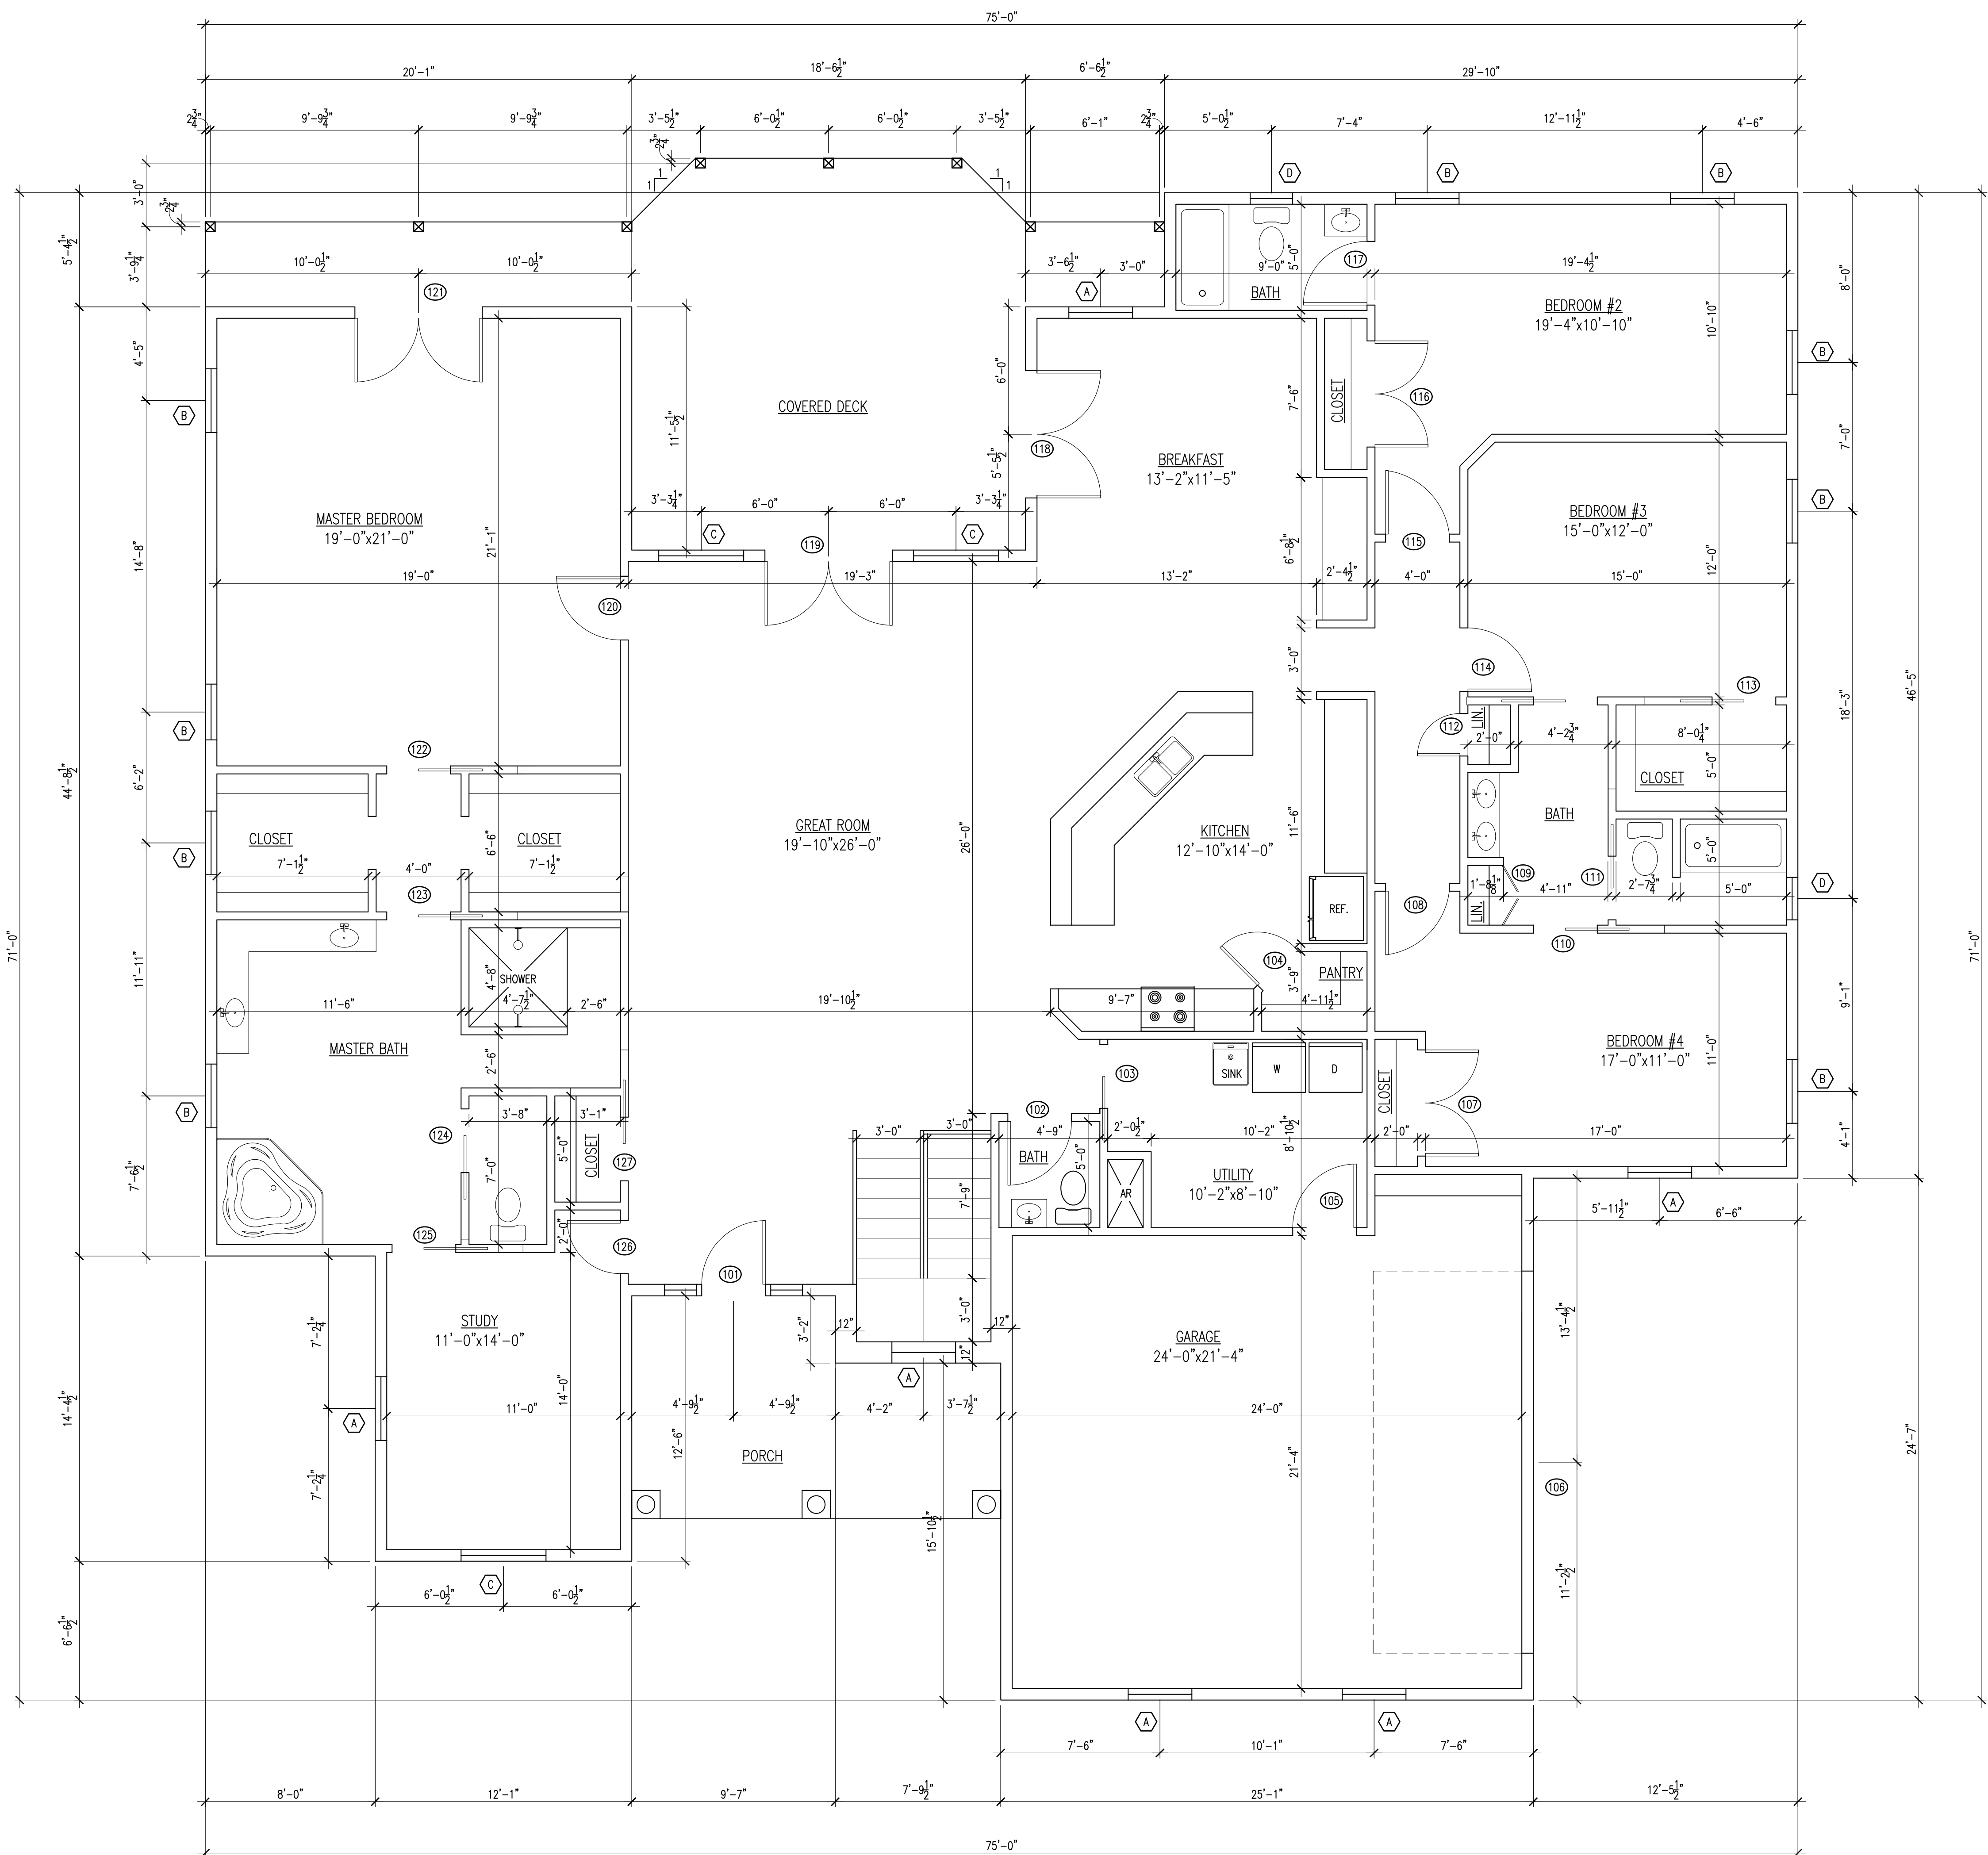

DOOR SCHEDULE


MARK	DOOR SIZE			THK	NOTES
	WD	HGT			
101	3'-0"	6'-8"	PER MFR.		EXTERIOR DOOR w/ SIDE LIGHTS
102	3'-0"	6'-8"	PER MFR.		-
103	3'-0"	6'-8"	PER MFR.		POCKET DOOR
104	3'-0"	6'-8"	PER MFR.		-
105	3'-0"	6'-8"	PER MFR.		-
106	18'-0"	7'-0"	PER MFR.		OVERHEAD GARAGE DOOR
107	5'-0"	6'-8"	PER MFR.		DOUBLE DOOR
108	3'-0"	6'-8"	PER MFR.		-
109	2'-8"	6'-8"	PER MFR.		DOUBLE DOOR
110	3'-0"	6'-8"	PER MFR.		POCKET DOOR
111	3'-0"	6'-8"	PER MFR.		POCKET DOOR
112	2'-0"	6'-8"	PER MFR.		-
113	3'-0"	6'-8"	PER MFR.		POCKET DOOR
114	3'-0"	6'-8"	PER MFR.		-
115	3'-0"	6'-8"	PER MFR.		-
116	5'-0"	6'-8"	PER MFR.		DOUBLE DOOR
117	3'-0"	6'-8"	PER MFR.		-
118	6'-0"	6'-8"	PER MFR.		EXTERIOR DOUBLE DOOR
119	6'-0"	6'-8"	PER MFR.		EXTERIOR DOUBLE DOOR
120	3'-0"	6'-8"	PER MFR.		-
121	6'-0"	6'-8"	PER MFR.		EXTERIOR DOUBLE DOOR
122	3'-0"	6'-8"	PER MFR.		POCKET DOOR
123	3'-0"	6'-8"	PER MFR.		POCKET DOOR
124	3'-0"	6'-8"	PER MFR.		POCKET DOOR
125	3'-0"	6'-8"	PER MFR.		POCKET DOOR
126	3'-0"	6'-8"	PER MFR.		-
127	3'-0"	6'-8"	PER MFR.		POCKET DOOR

NOTES:

WINDOW SCHEDULE

MARK	SIZE		TYPE	NOTES
	WIDTH	HEIGHT		
A	3'-0"	5'-6"	DOUBLE HUNG	-
B	3'-0"	4'-0"	DOUBLE HUNG	-
C	4'-0"	5'-6"	DOUBLE HUNG	-
D	2'-0"	3'-0"	DOUBLE HUNG	-
E	3'-0"	3'-0"	DOUBLE HUNG	-
F	3'-0"	5'-0"	DOUBLE HUNG	-

NOTES:

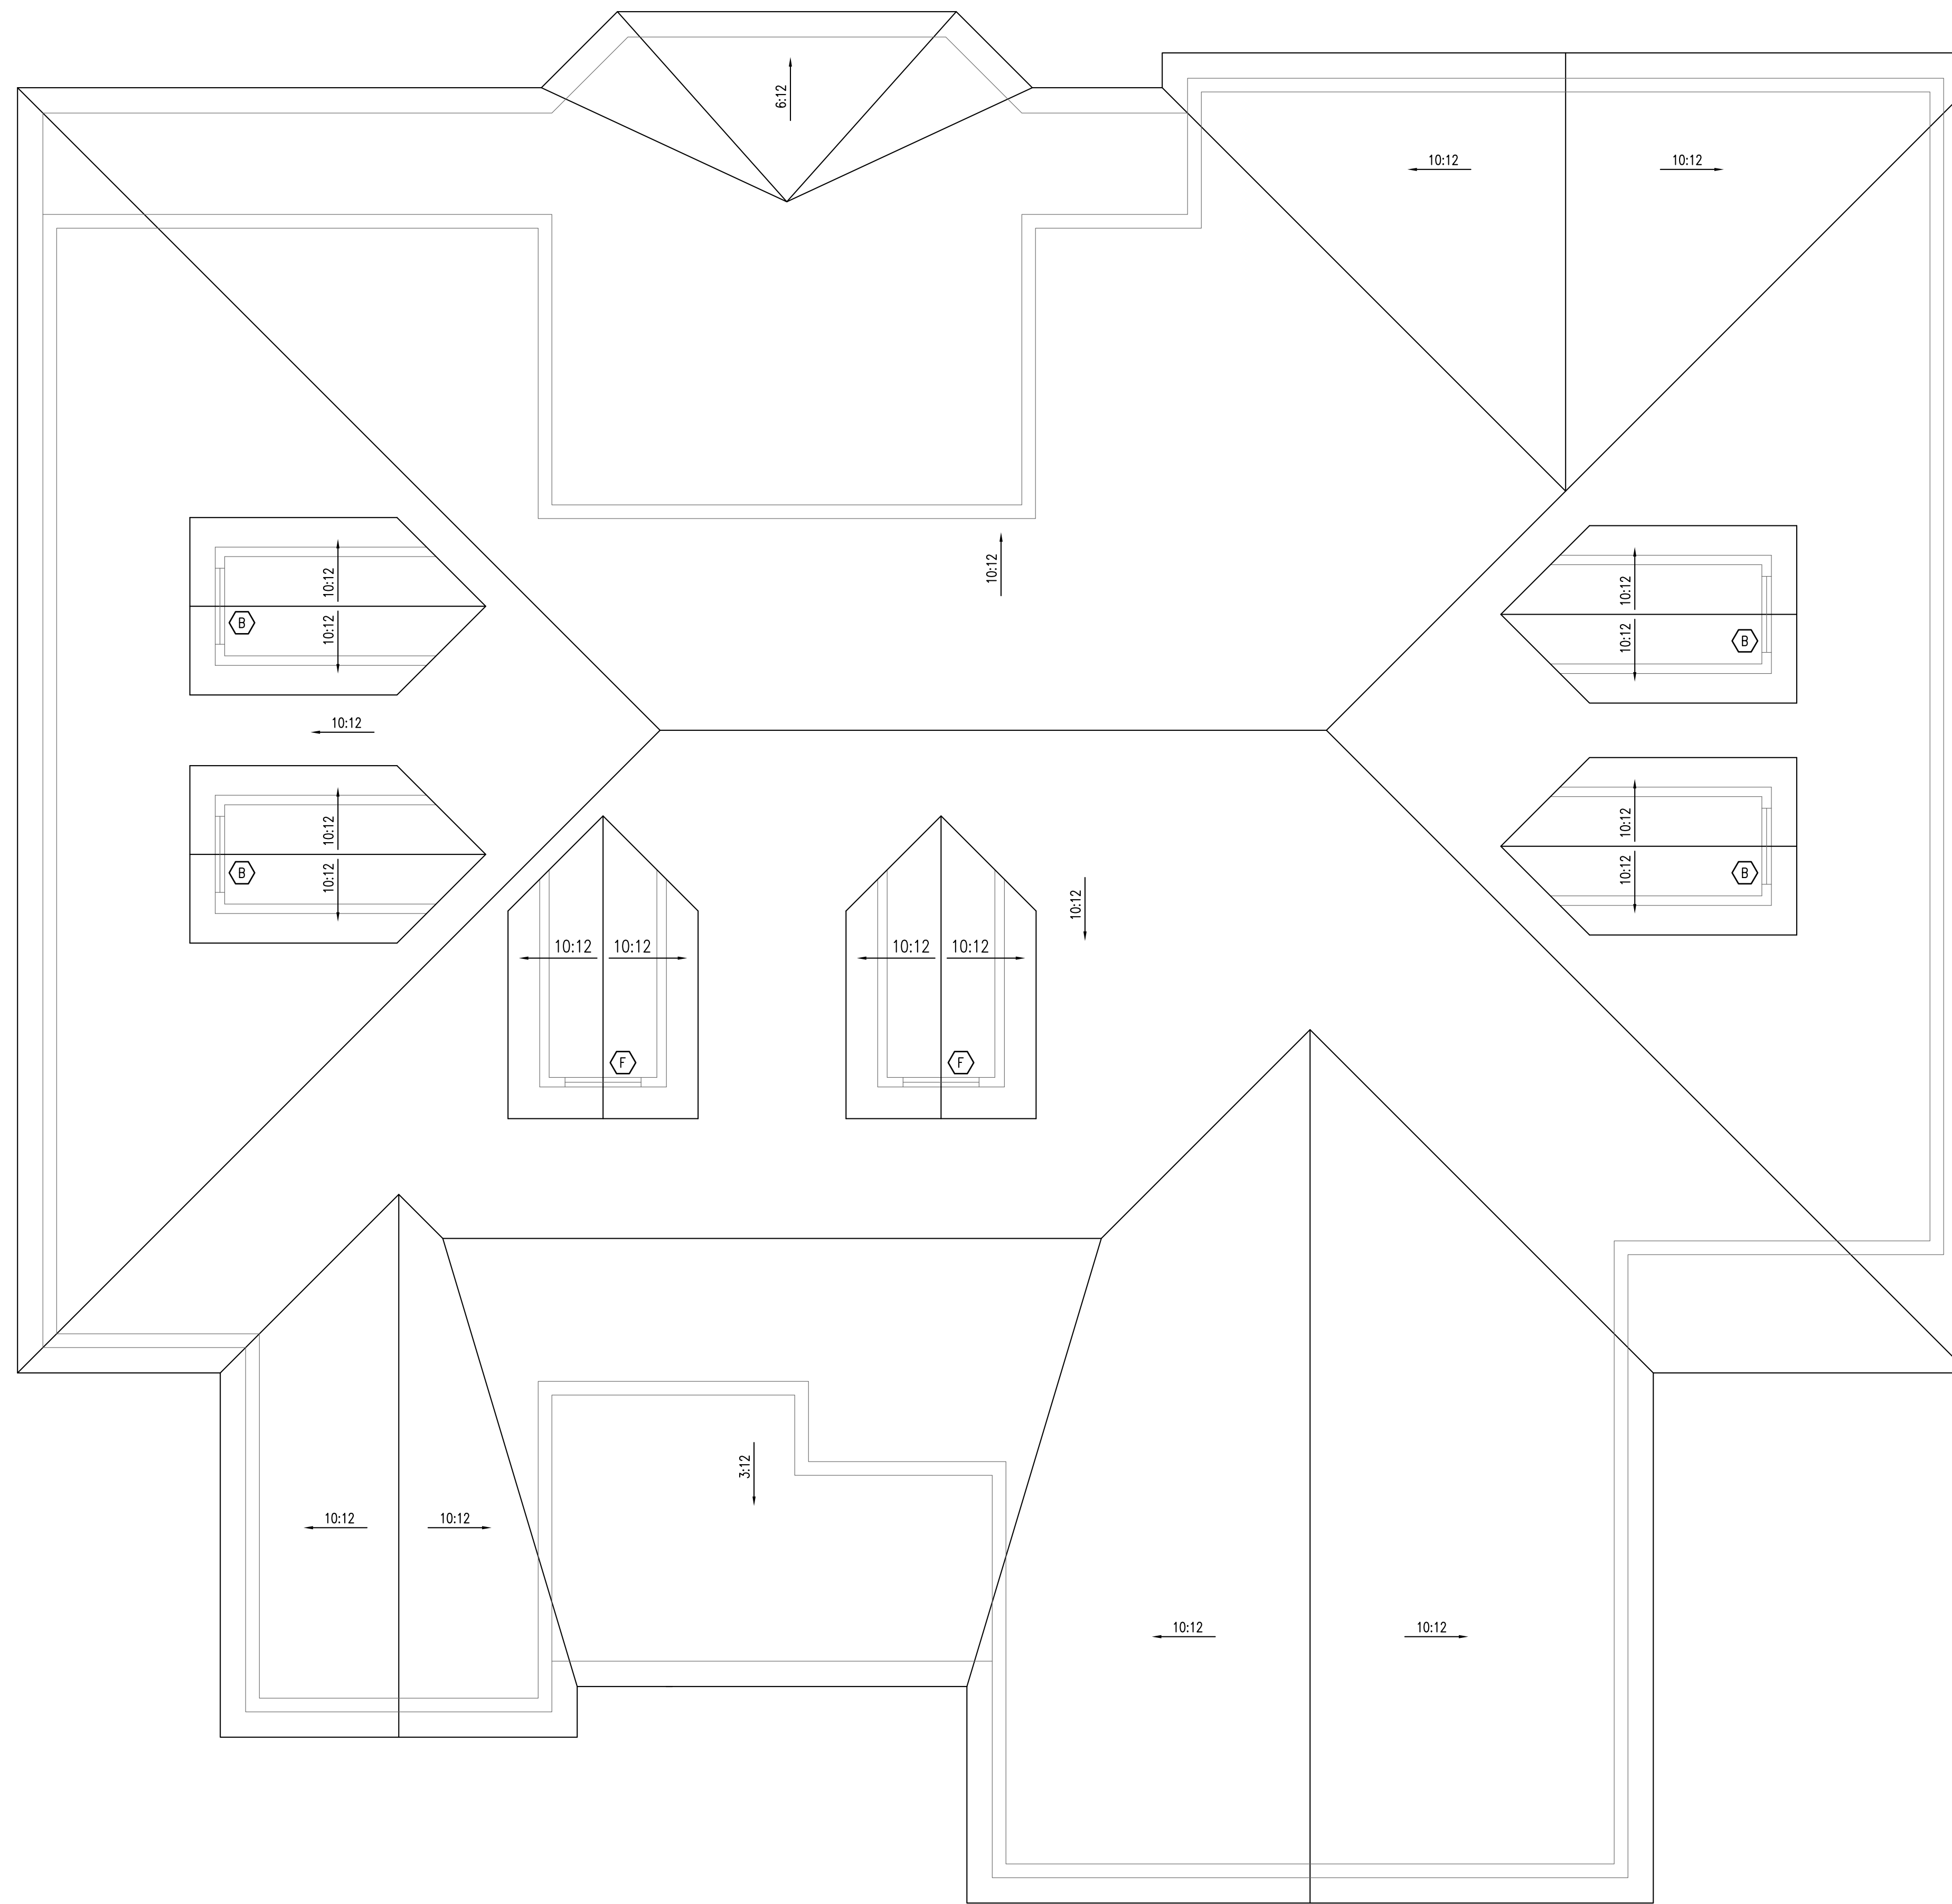

ALL DESIGN SHOWN HAS BEEN UNDER THE DIRECTION OF THE OWNER, SCOTT HILL. NO CODE CHECKS HAVE BEEN PERFORMED. GC SHALL COORDINATE ALL DESIGN REQUIREMENTS ON ACCORDANCE WITH THE VIRGINIA UNIFORM STATEWIDE BUILDING CODE.

IF THIS BAR IS NOT EXACTLY ONE INCH LONG, THIS DRAWING HAS NOT BEEN REPRODUCED AT FULL SCALE

PROJECT
 HILL RESIDENCE
 PEAKLAND WAY LOT 63
 MONTGOMERY COUNTY, VA


REV.	DESCRIPTION	DATE

SHEET NAME
 ROOF PLAN

PROJECT NO. 08-1103	SHEET A3
DATE 13-JAN-09	03 OF 06

ALL DESIGN SHOWN HAS BEEN UNDER THE DIRECTION OF THE OWNER, SCOTT HILL. NO CODE CHECKS HAVE BEEN PERFORMED. GC SHALL COORDINATE ALL DESIGN REQUIREMENTS ON ACCORDANCE WITH THE VIRGINIA UNIFORM STATEWIDE BUILDING CODE.

ICON	DESCRIPTION	NOTES
\$	SINGLE POLE SWITCH	GENERIC WHITE
\$,	3 WAY SWITCH	GENERIC WHITE
D	SINGLE POLE DIMMER	TOGGLE STYLE
D	ILLUMINATED DIMMER	
T	TIMER	LEVITON 6530M (5-10-20-30 MIN), WHITE
○	7" RECESSED CAN	HALO H7ICT, BAFFLE TBD
⊙	4" RECESSED CAN	HALO H99ICT, 993W BAFFLE (WHITE COILEX)
□	FLOOD LIGHT	TBD
F	FAN SWITCH	AS SUPPLIED W/ FAN
⊙	CEILING FIXTURE / PENDANT	MODEL TBD
⊙	CEILING FAN	INTERIOR: MODEL (TBD) EXTERIOR: MODEL (TBD)
⊗	EXHAUST FAN	BROAN S80U (0.6 SONE)
—	FLOURESCENT STRIP	LENGTH AS SHOWN, RAPID START, SINGLE TUBE
∇	VACUUM PORT	NUTONE
∩	WALL FIXTURE	

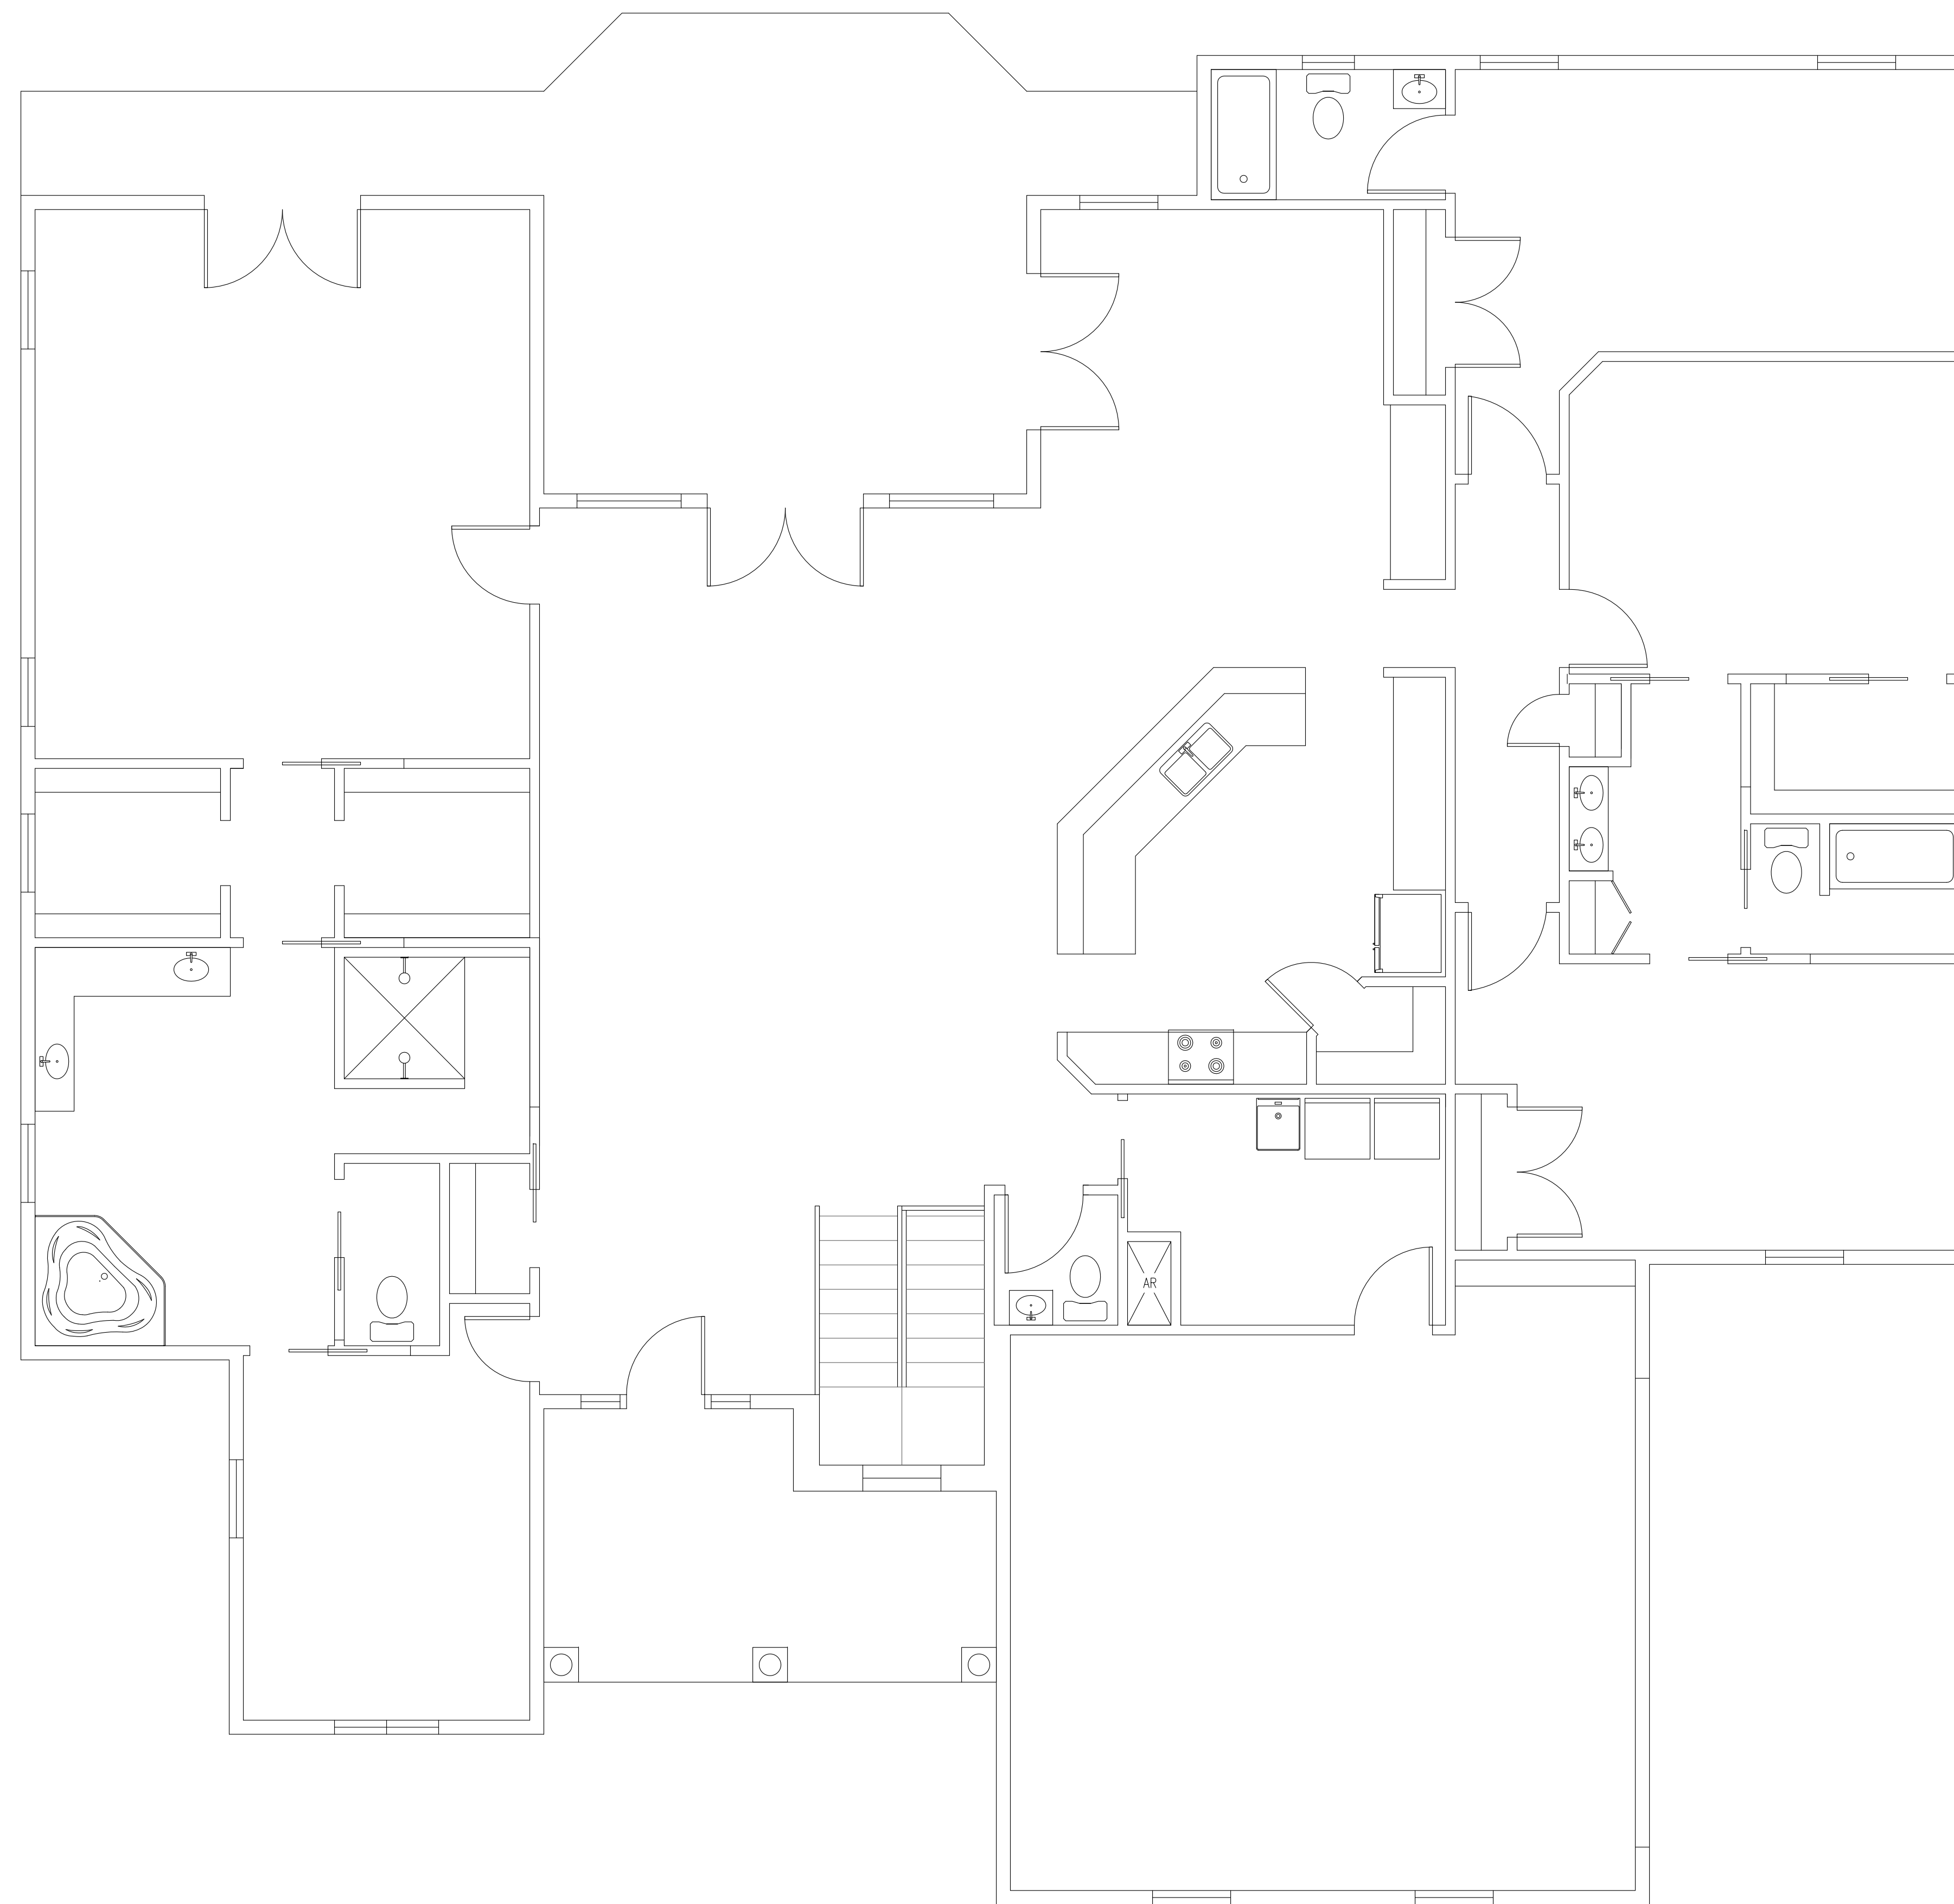

IF THIS BAR IS NOT EXACTLY ONE INCH LONG, THIS DRAWING HAS NOT BEEN REPRODUCED AT FULL SCALE

PROJECT
HILL RESIDENCE
 PEAKLAND WAY LOT 63
 MONTGOMERY COUNTY, VA

REV.	DESCRIPTION	DATE

SHEET NAME
ELECTRICAL PLAN

PROJECT NO. 08-1103	SHEET A4
DATE 13-JAN-09	04 OF 06

ALL DESIGN SHOWN HAS BEEN UNDER THE DIRECTION OF THE OWNER, SCOTT HILL. NO CODE CHECKS HAVE BEEN PERFORMED. GC SHALL COORDINATE ALL DESIGN REQUIREMENTS ON ACCORDANCE WITH THE VIRGINIA UNIFORM STATEWIDE BUILDING CODE.



LEFT SIDE ELEVATION

SCALE: 1/4" = 1'-0" 2



FRONT ELEVATION

SCALE: 1/4" = 1'-0" 1

IF THIS BAR IS NOT EXACTLY ONE INCH LONG, THIS DRAWING HAS NOT BEEN REPRODUCED AT FULL SCALE


PROJECT
 HILL RESIDENCE
 PEAKLAND WAY LOT 63
 MONTGOMERY COUNTY, VA

REV.	DESCRIPTION	DATE

SHEET NAME
 ELEVATIONS

PROJECT NO. 08-1103	SHEET A5
DATE 13-JAN-09	05 OF 06

ALL DESIGN SHOWN HAS BEEN UNDER THE DIRECTION OF THE OWNER, SCOTT HILL. NO CODE CHECKS HAVE BEEN PERFORMED. GC SHALL COORDINATE ALL DESIGN REQUIREMENTS ON ACCORDANCE WITH THE VIRGINIA UNIFORM STATEWIDE BUILDING CODE.

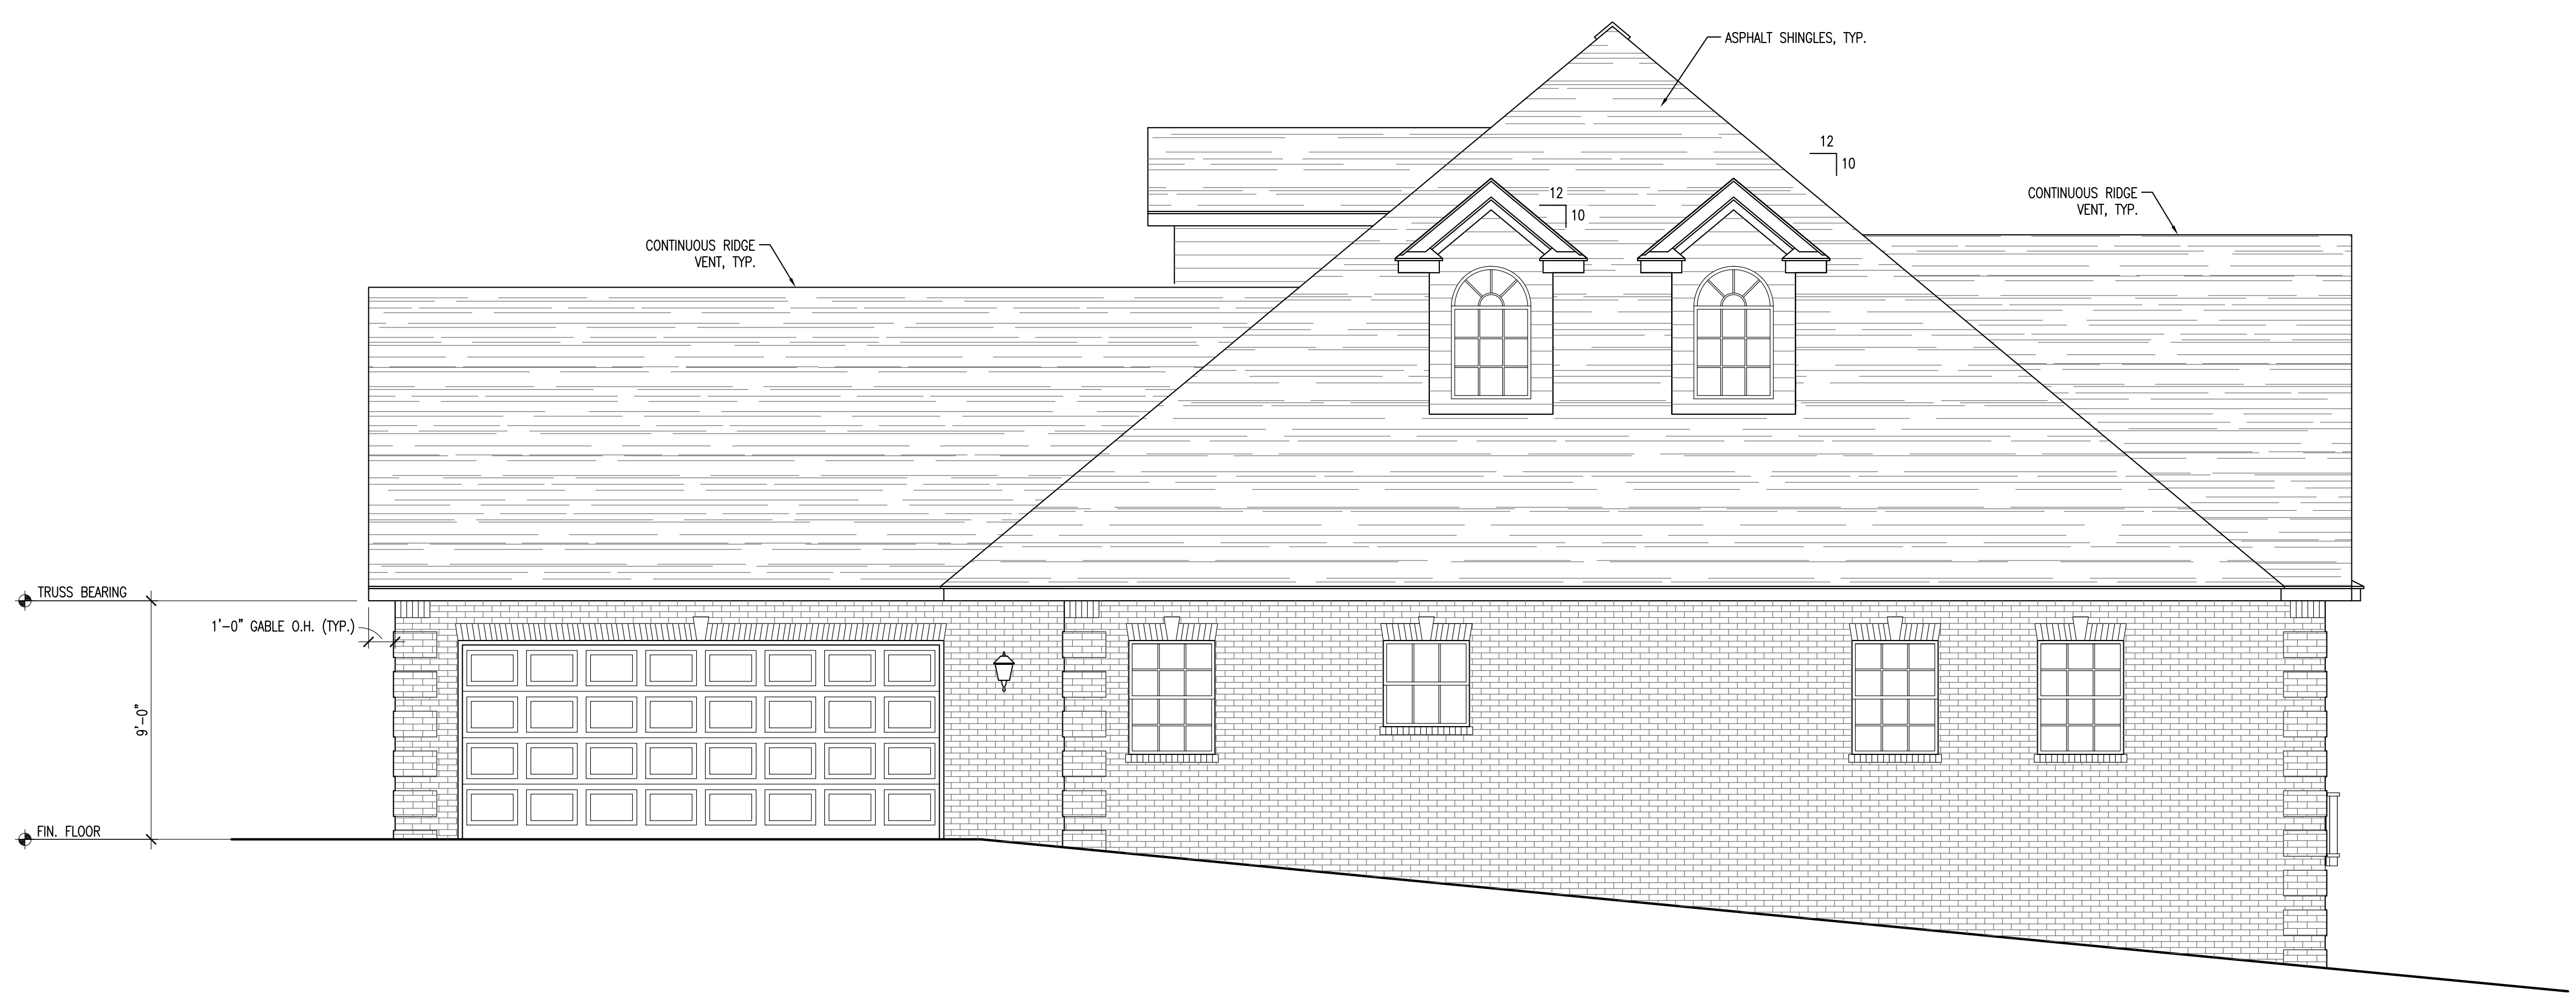

RIGHT SIDE ELEVATION

SCALE: 1/4" = 1'-0" 2

IF THIS BAR IS NOT EXACTLY ONE INCH LONG, THIS DRAWING HAS NOT BEEN REPRODUCED AT FULL SCALE



REAR ELEVATION

SCALE: 1/4" = 1'-0" 1

PROJECT
HILL RESIDENCE
PEAKLAND WAY LOT 63
MONTGOMERY COUNTY, VA


REV.	DESCRIPTION	DATE

SHEET NAME
ELEVATIONS


PROJECT NO. 08-1103	SHEET A6
DATE 24-JUL-09	OF 06 OF 06

ALL DESIGN SHOWN HAS BEEN UNDER THE DIRECTION OF THE OWNER, SCOTT HILL. NO CODE CHECKS HAVE BEEN PERFORMED. GC SHALL COORDINATE ALL DESIGN REQUIREMENTS ON ACCORDANCE WITH THE VIRGINIA UNIFORM STATEWIDE BUILDING CODE.


NOT USED	NOT USED	NOT USED
DETAIL NOT USED	NO SCALE 11	DETAIL NOT USED
NO SCALE 8	NO SCALE 5	NO SCALE 5
NOT USED	NOT USED	NOT USED
DETAIL NOT USED	NO SCALE 10	DETAIL NOT USED
NO SCALE 7	NO SCALE 4	NO SCALE 4
NOT USED	NOT USED	NOT USED
DETAIL NOT USED	NO SCALE 9	DETAIL NOT USED
NO SCALE 6	NO SCALE 3	NO SCALE 3

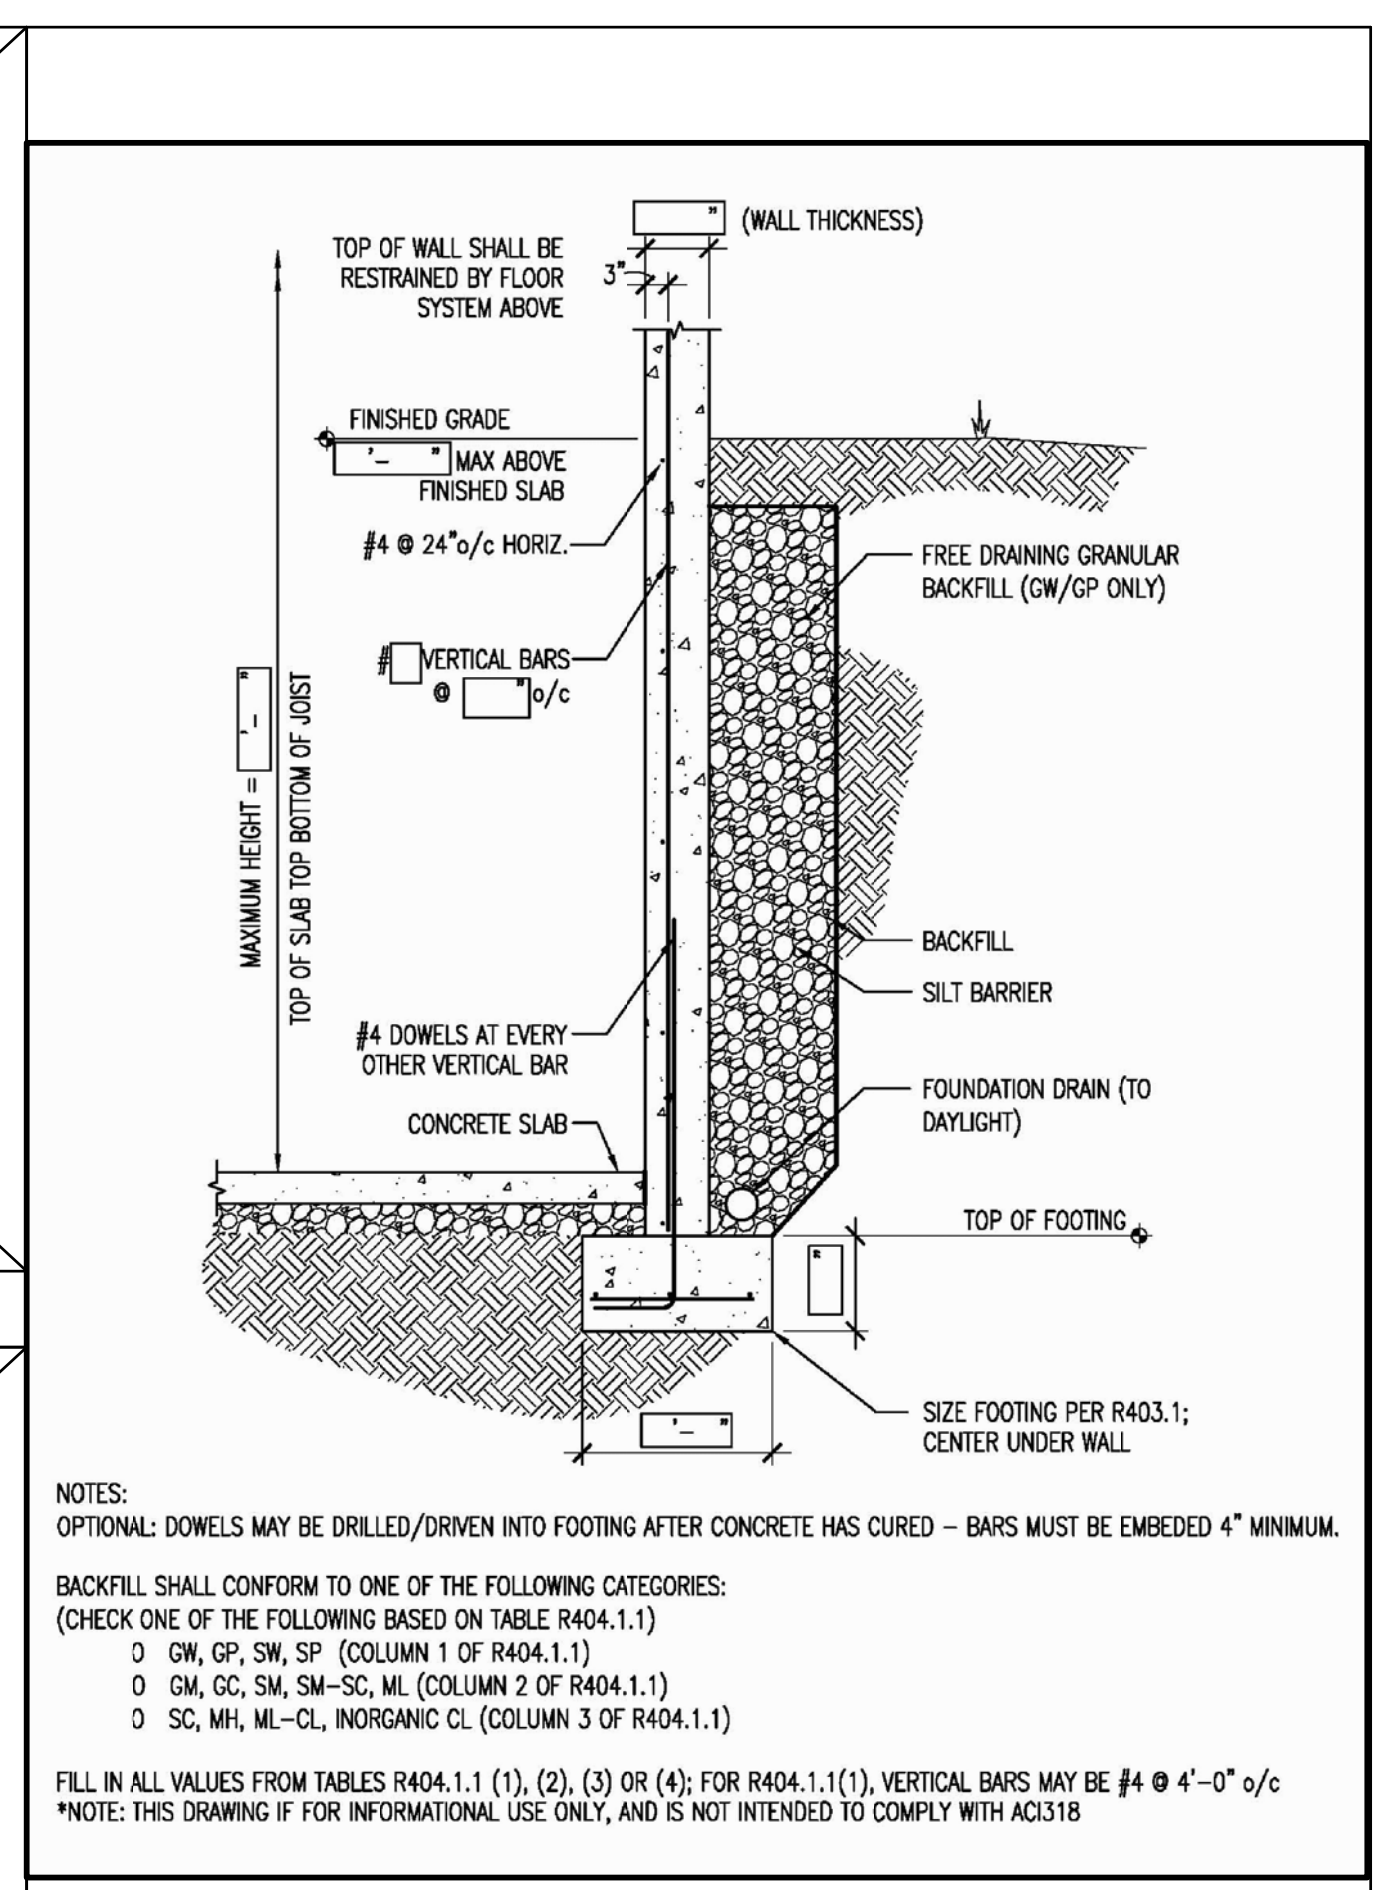

IRC FILL-IN CHART NOT TO SCALE 2

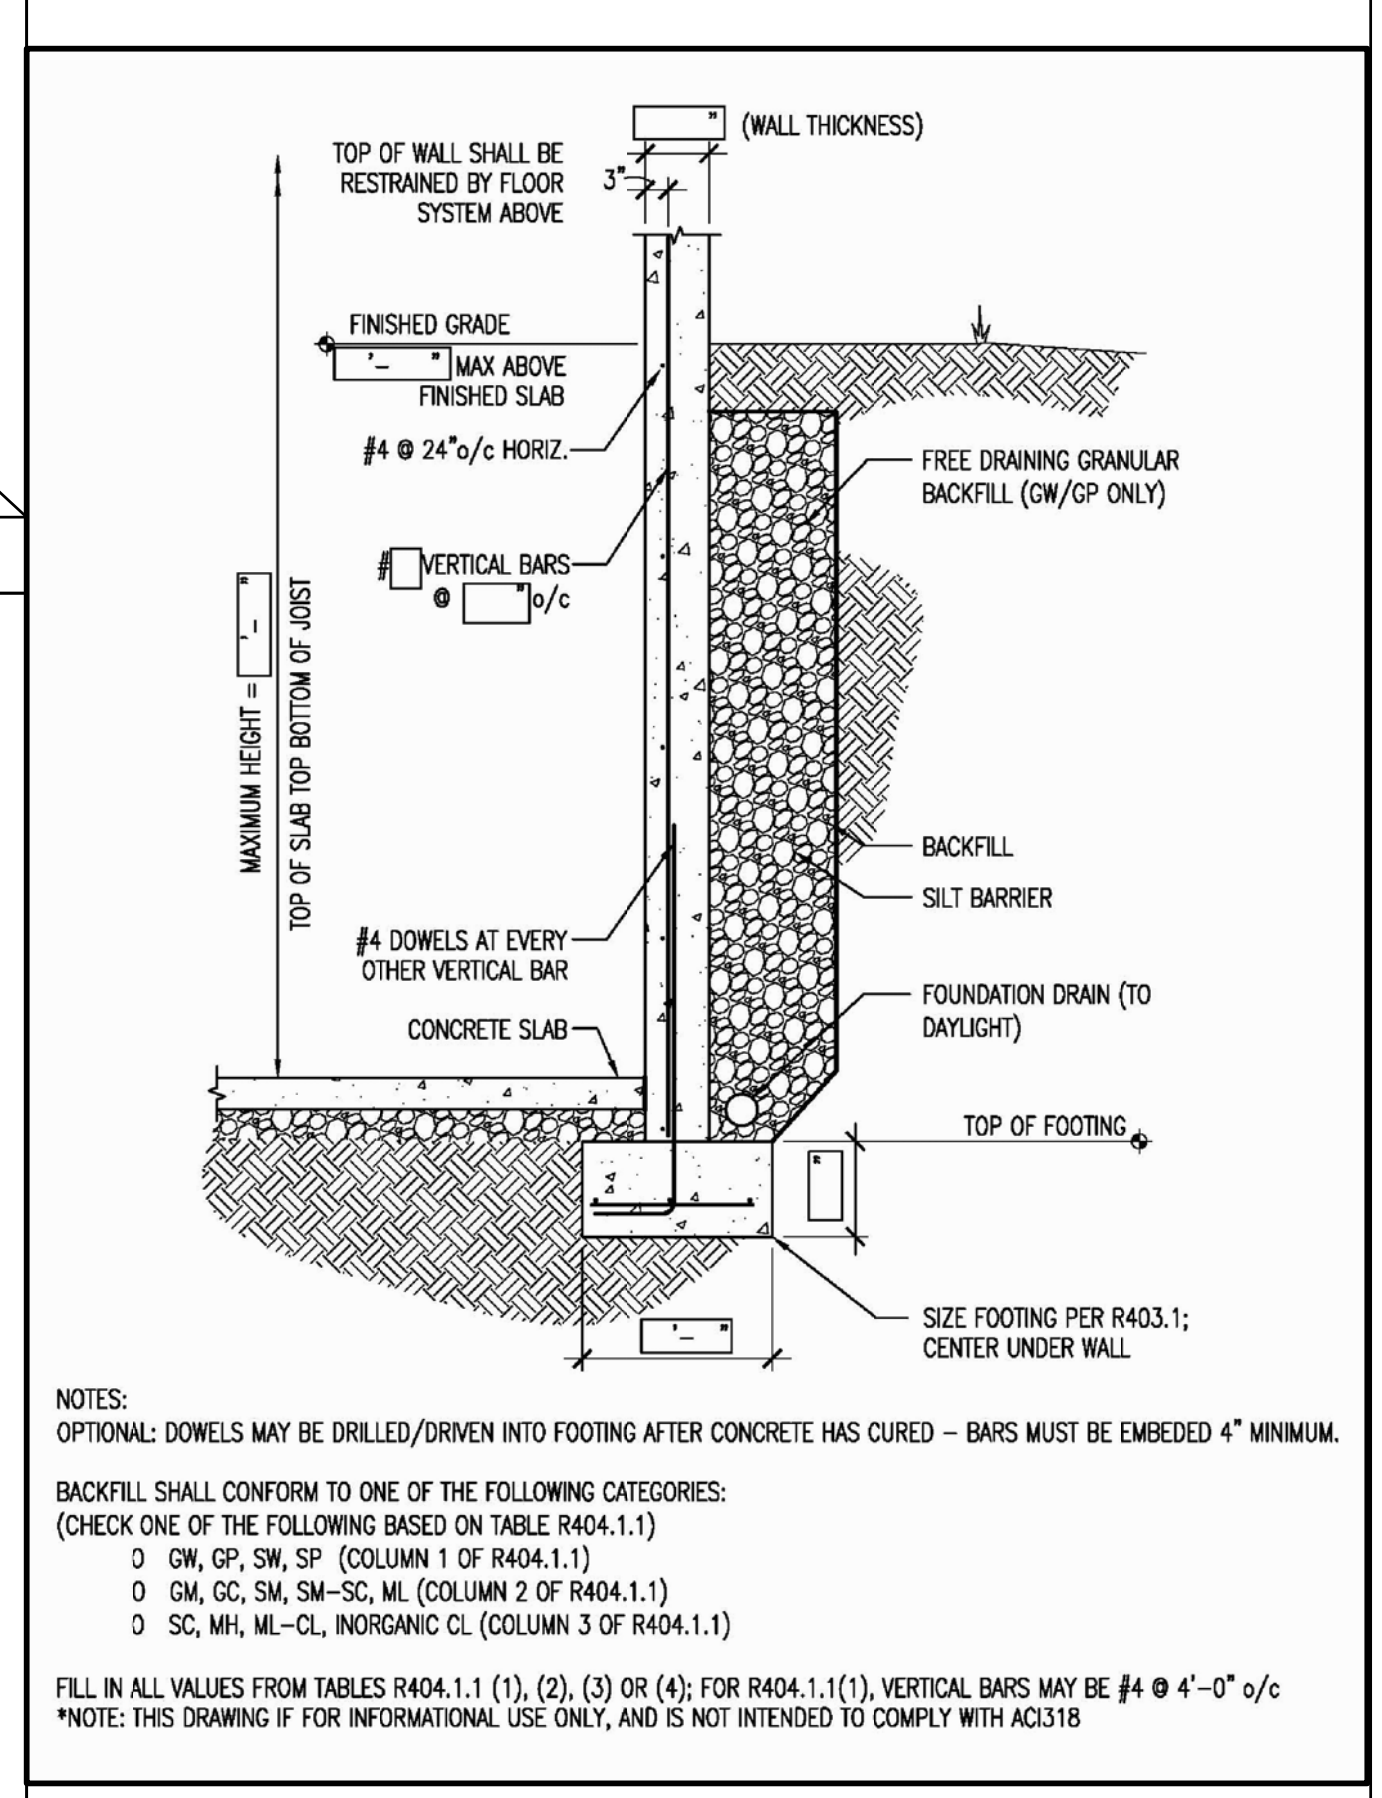

IRC FILL-IN CHART NOT TO SCALE 1

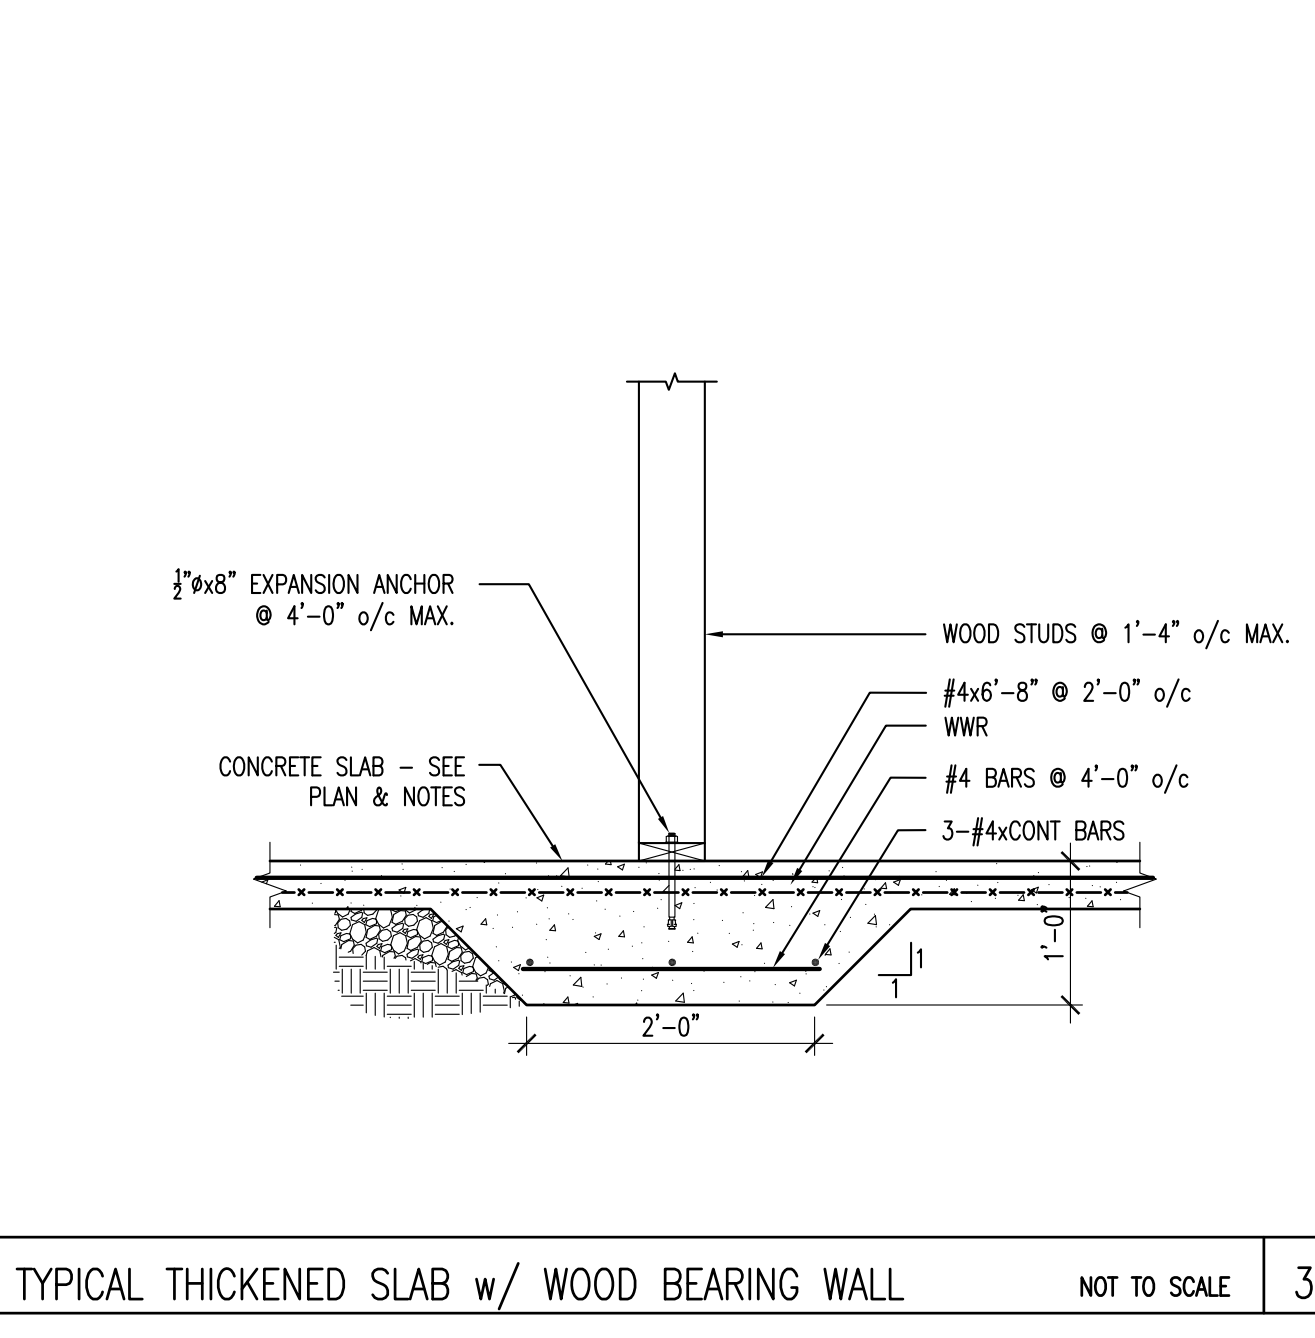

TYPICAL THICKENED SLAB w/ WOOD BEARING WALL NOT TO SCALE 3

IF THIS BAR IS NOT EXACTLY ONE INCH LONG, THIS DRAWING HAS NOT BEEN REPRODUCED AT FULL SCALE

PROJECT
HILL RESIDENCE
PEAKLAND WAY LOT 63
MONTGOMERY COUNTY, VA

REV.	DESCRIPTION	DATE

SHEET NAME
IRC-FILL IN CHART & THICKENED SLAB

PROJECT NO. 08-1103	SHEET A7
DATE 13-JAN-09	07 OF 06